


NOTES:

DEPARTMENT OF PUBLIC WORKS N.S.W. W. K. PILZ Director of Public Works	KELSO HIGH SCHOOL NEW SCHOOL	PLAN RM. No. SB2503-13/4
C. R. WEATHERBURN Government Architect Principal Engineer	FLEXIBLE LEARNING UNIT (FLU) BLOCK B	NUMBER IN SET 28 SHEET NUMBER 4
W. R. BATES Deputy Chief Engineer Govt. Architects Branch	LIGHTING LAYOUT	SCALES: 1:100

ROLL 559

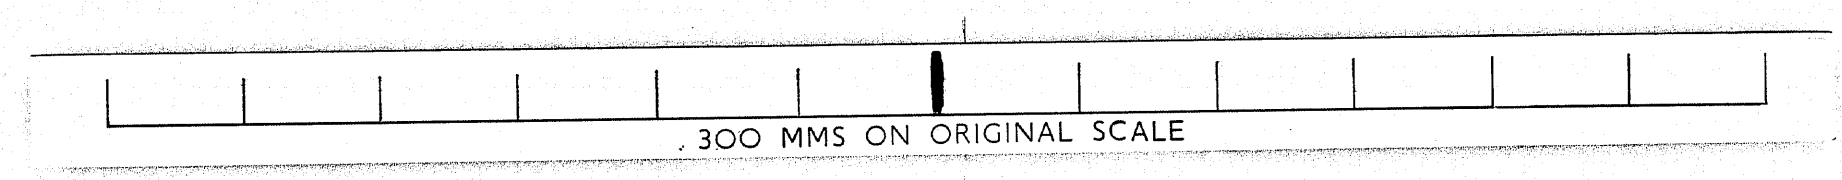

A1