



GROUND FLOOR

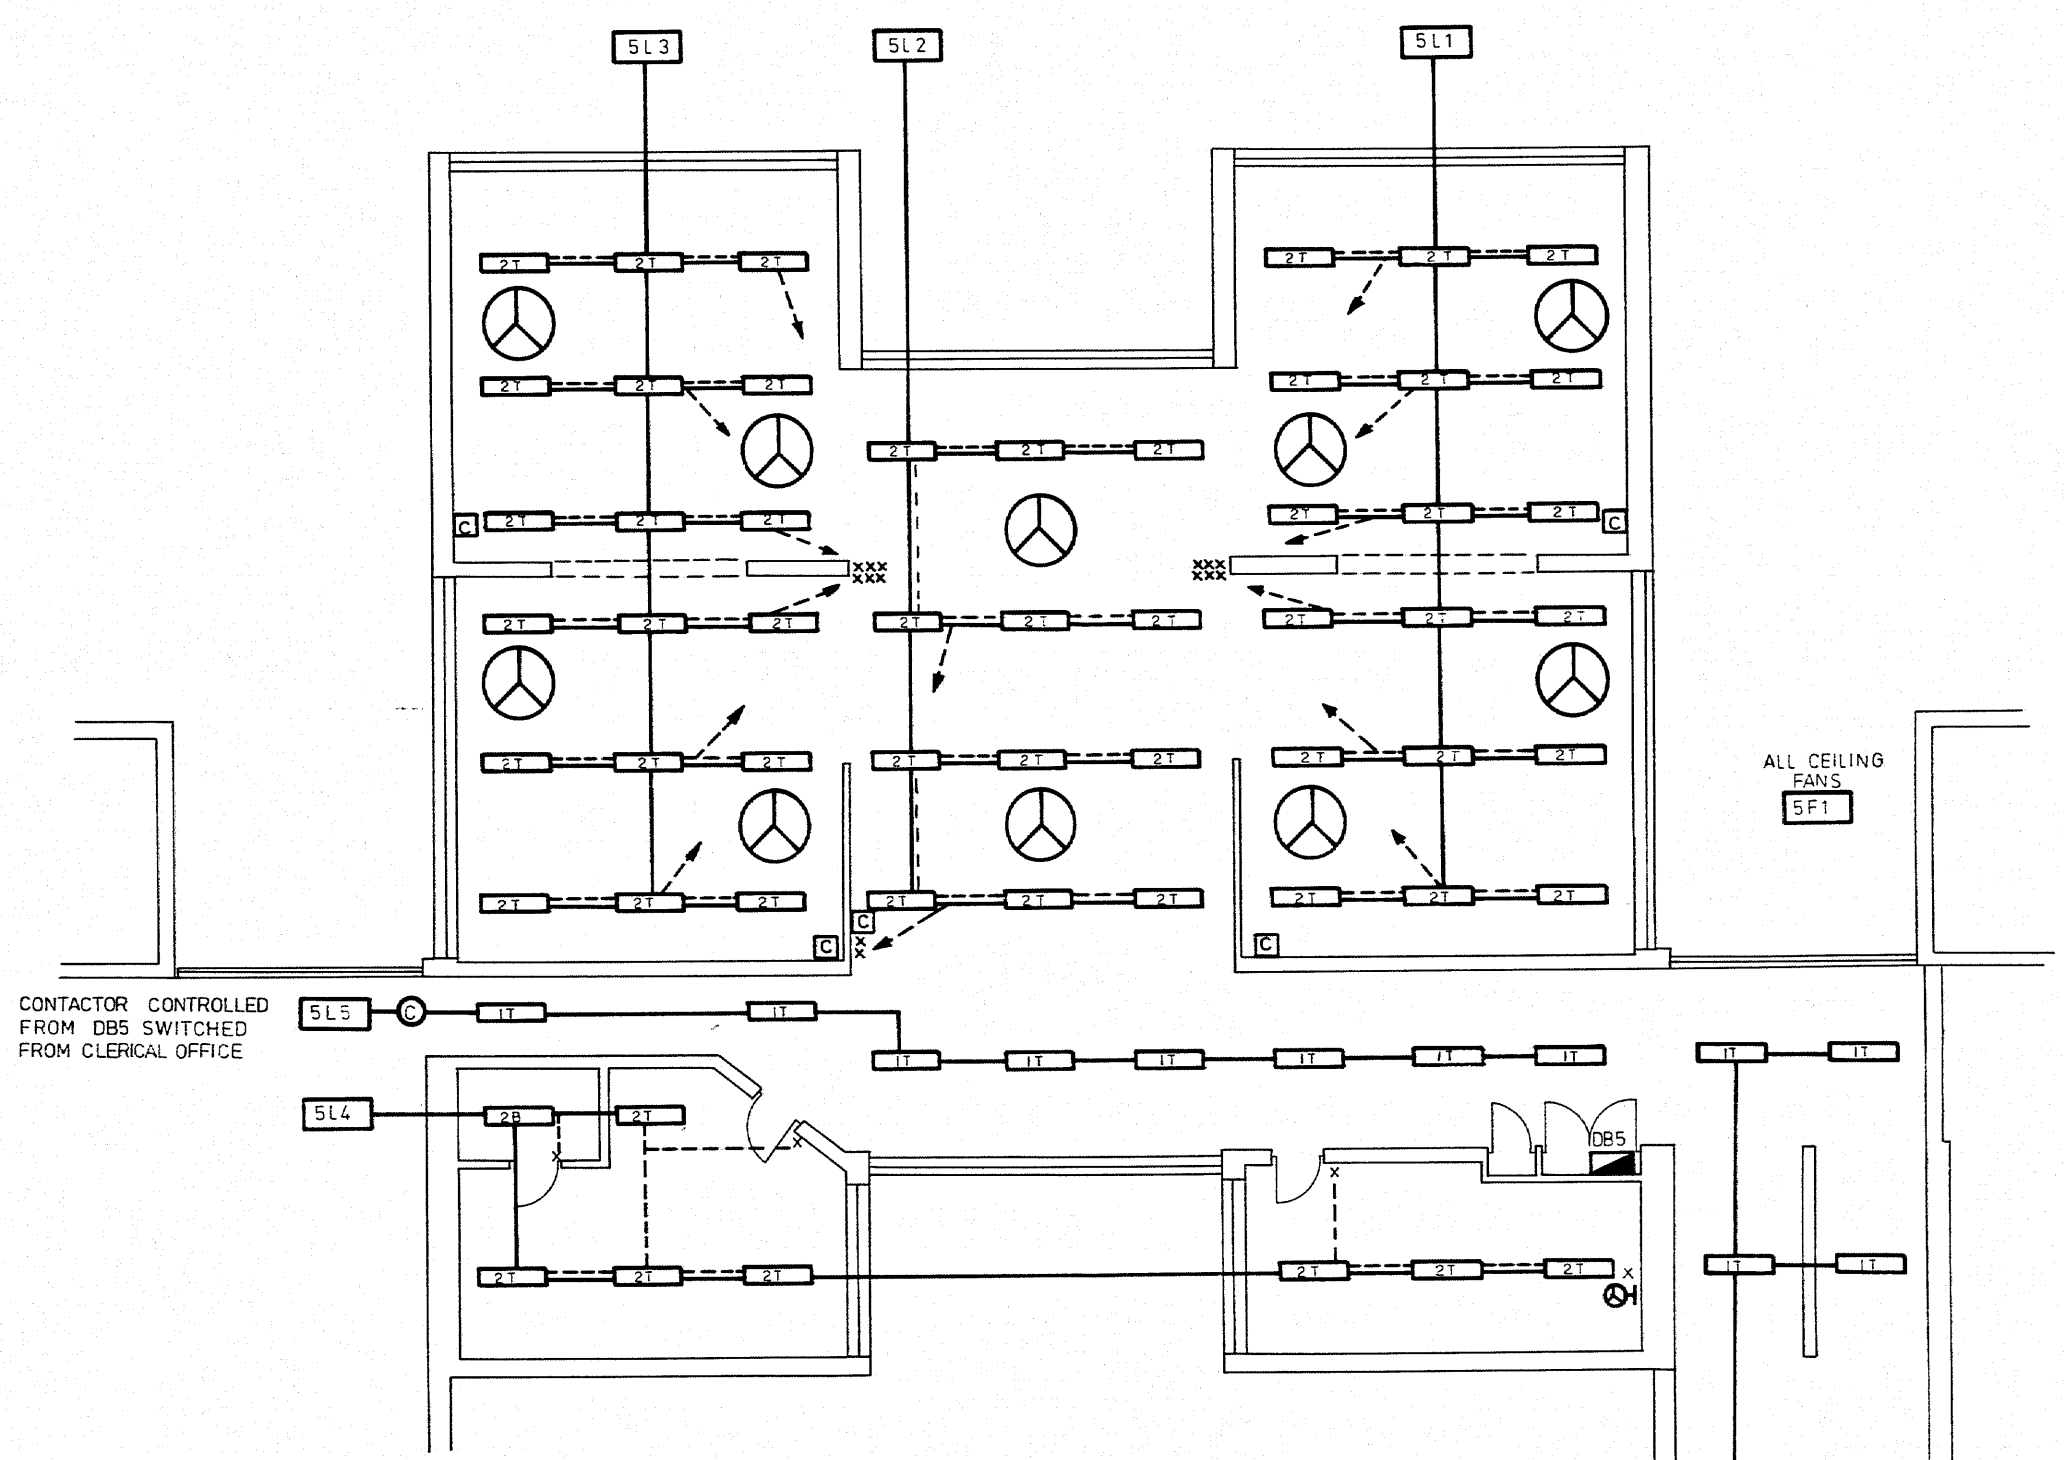


FIRST FLOOR

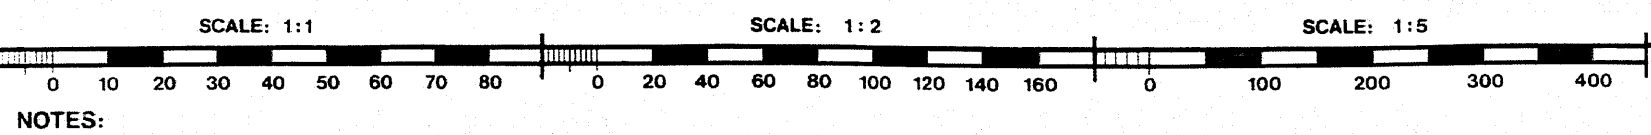

NOTES:

DEPARTMENT OF PUBLIC WORKS N.S.W. W. K. PILZ Director of Public Works	KELSO HIGH SCHOOL NEW SCHOOL	PLAN RM. No. SB 2503-13/6	FC
C. P. WEATHERBURN Government Architect <i>C. P. Weatherburn</i> Principal Engineer Schools	FLEXIBLE LEARNING UNIT (FLU) BLOCK C	NUMBER IN SET 28	SHEET NUMBER 6
W. R. BATES Deputy Chief Engineer Govt. Architect's Branch	LIGHTING LAYOUT	SCALES: 1:100	

ROLL 559

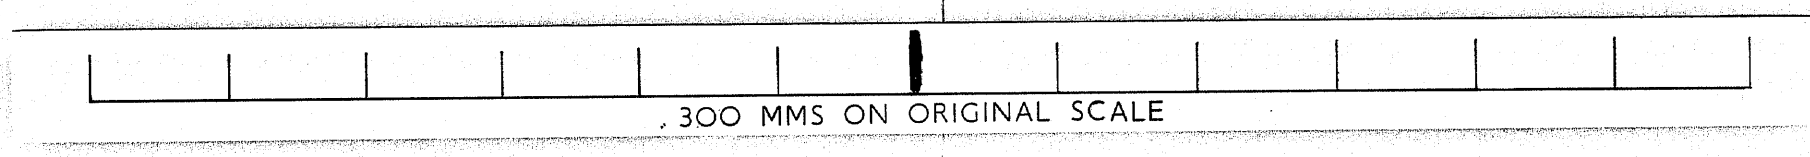

A1