


- NOTES:
- SWITCH PANEL (LOCKABLE) FOR THEATRETTE CONSISTING OF ONE SWITCH FOR GENERAL HALL LIGHTS (7L1)
 - ADJUSTABLE WALLWASHER FOR PANEL LIGHT DIMMING
 - LIGHTING CONTROL PANEL REFER TO SHEET NO 24
 - EXIT LIGHTS MOUNTED AT 2300 ABOVE FLOOR 7L5
 - SAFETY LIGHTS MOUNTED AT 2300 ABOVE FLOOR 7L5
 - AISLE LIGHTS 7L7
 - EMERGENCY PANIC SWITCH
 - 125 W MV COLOUR CORRECTED LAMPS IN CEILING MOUNTED "HEMISPHERES" (7L4)
 - LIGHTS IN CIRCUIT 7L2 AND IN STAGE AREA TO HAVE DIMMING BALLASTS

DEPARTMENT OF PUBLIC WORKS N.S.W. W. K. PILZ Director of Public Works		KELSO HIGH SCHOOL NEW SCHOOL		PLAN RM. No. SB2503-13/10	
C. R. WEATHERBURN Government Architect Principal Engineer Schools		THEATRETTE AND MUSIC BLOCK E		NUMBER IN SET 28	
W. R. BATES Deputy Chief Engineer Govt. Architects Branch		LIGHTING LAYOUT		SHEET NUMBER 10	
SCALES: 1:100					

ROLL 559

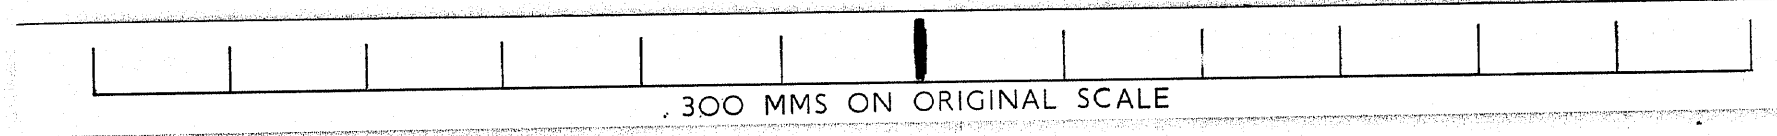

A1