


NOTES: 1) MERCURY VAPOUR FITTINGS IN LIBRARY VOID AREAS ARE TO BE MOUNTED WITH THE UNDERSIDE OF THE FITTINGS LEVEL WITH THE BOTTOM CHORDS OF THE TRUSSES IN THEIR RESPECTIVE AREAS.	(M) MERCURY VAPOUR LAMPS IN CYLINDERS AS SPECIFIED A 175 WATTS 650mm CYLINDERS B 100 WATTS 650mm CYLINDERS (SP) SWITCH PANEL (LIBRARY LIGHTING)	DEPARTMENT OF PUBLIC WORKS N.S.W. W. K. PILZ Director of Public Works	KELSO HIGH SCHOOL NEW SCHOOL	PLAN RM. No. SB2503-13/12
		C. P. WEATHERBURN Government Architect <i>Howe 22/7/66</i> W. R. BATES Deputy Chief Engineer Govt. Architects Branch	LIBRARY BLOCK F LIGHTING LAYOUT	NUMBER IN SET 28 SHEET NUMBER 12 SCALES: 1:100

ROLL 559

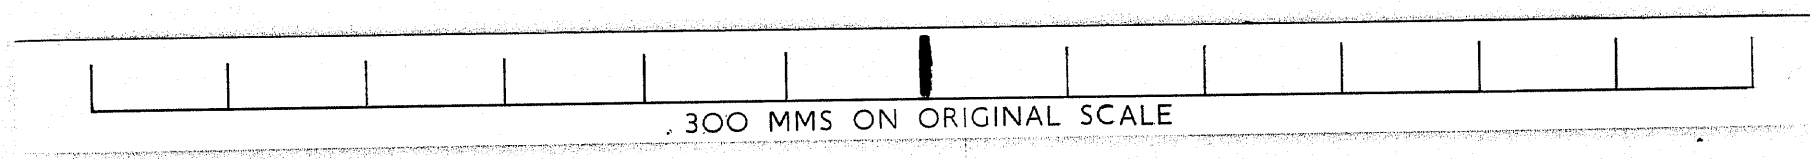

A1