


LEGEND:
 Ø DA - DRAINAGE ACCESS
 C.J. - CONTROL JOINT TO EXT. SKIN OF BRICKWORK, CHALK

	DEPARTMENT OF PUBLIC WORKS NEW SOUTH WALES W. K. PILZ DIRECTOR OF PUBLIC WORKS	DESIGN BY GOVERNMENT ARCHITECT CONSULTING ARCHITECT IAN REEER ASSOCIATES CONSULTING ENGINEER - STRUCTURAL BOND, JAMES, LARON PTY. LTD.	CONSULTING ENGINEER - ELECTRICAL DEPARTMENT OF PUBLIC WORKS CONSULTING ENGINEER - MECHANICAL DEPARTMENT OF PUBLIC WORKS CONSULTING ENGINEER - HYDRAULIC LEDINGHAM, HENSBY & PARTNERS PTY. LTD.	KELSO HIGH SCHOOL NEW SCHOOL BOYD ROAD, KELSO, BATHURST BLOCK H AND J FLOOR PLAN LEVEL 1	PLAN ROOM NUMBER SB 2503/26 NUMBER IN SET 199 SHEET NUMBER 26 SCALES 1:100
	C. P. WEATHERBURN GOVERNMENT ARCHITECT 2.9.76	FOLL 551			

300mm ON ORIGINAL

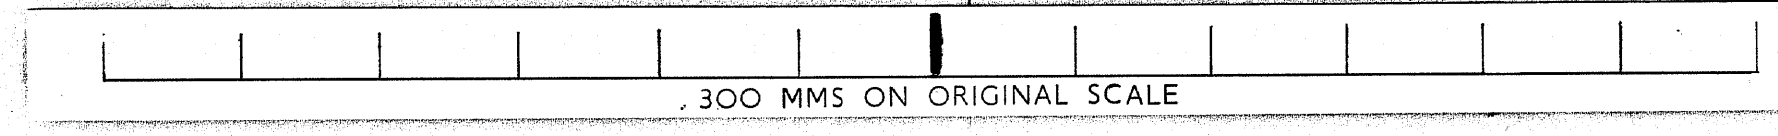

300 MMS ON ORIGINAL SCALE