



GROUND FLOOR

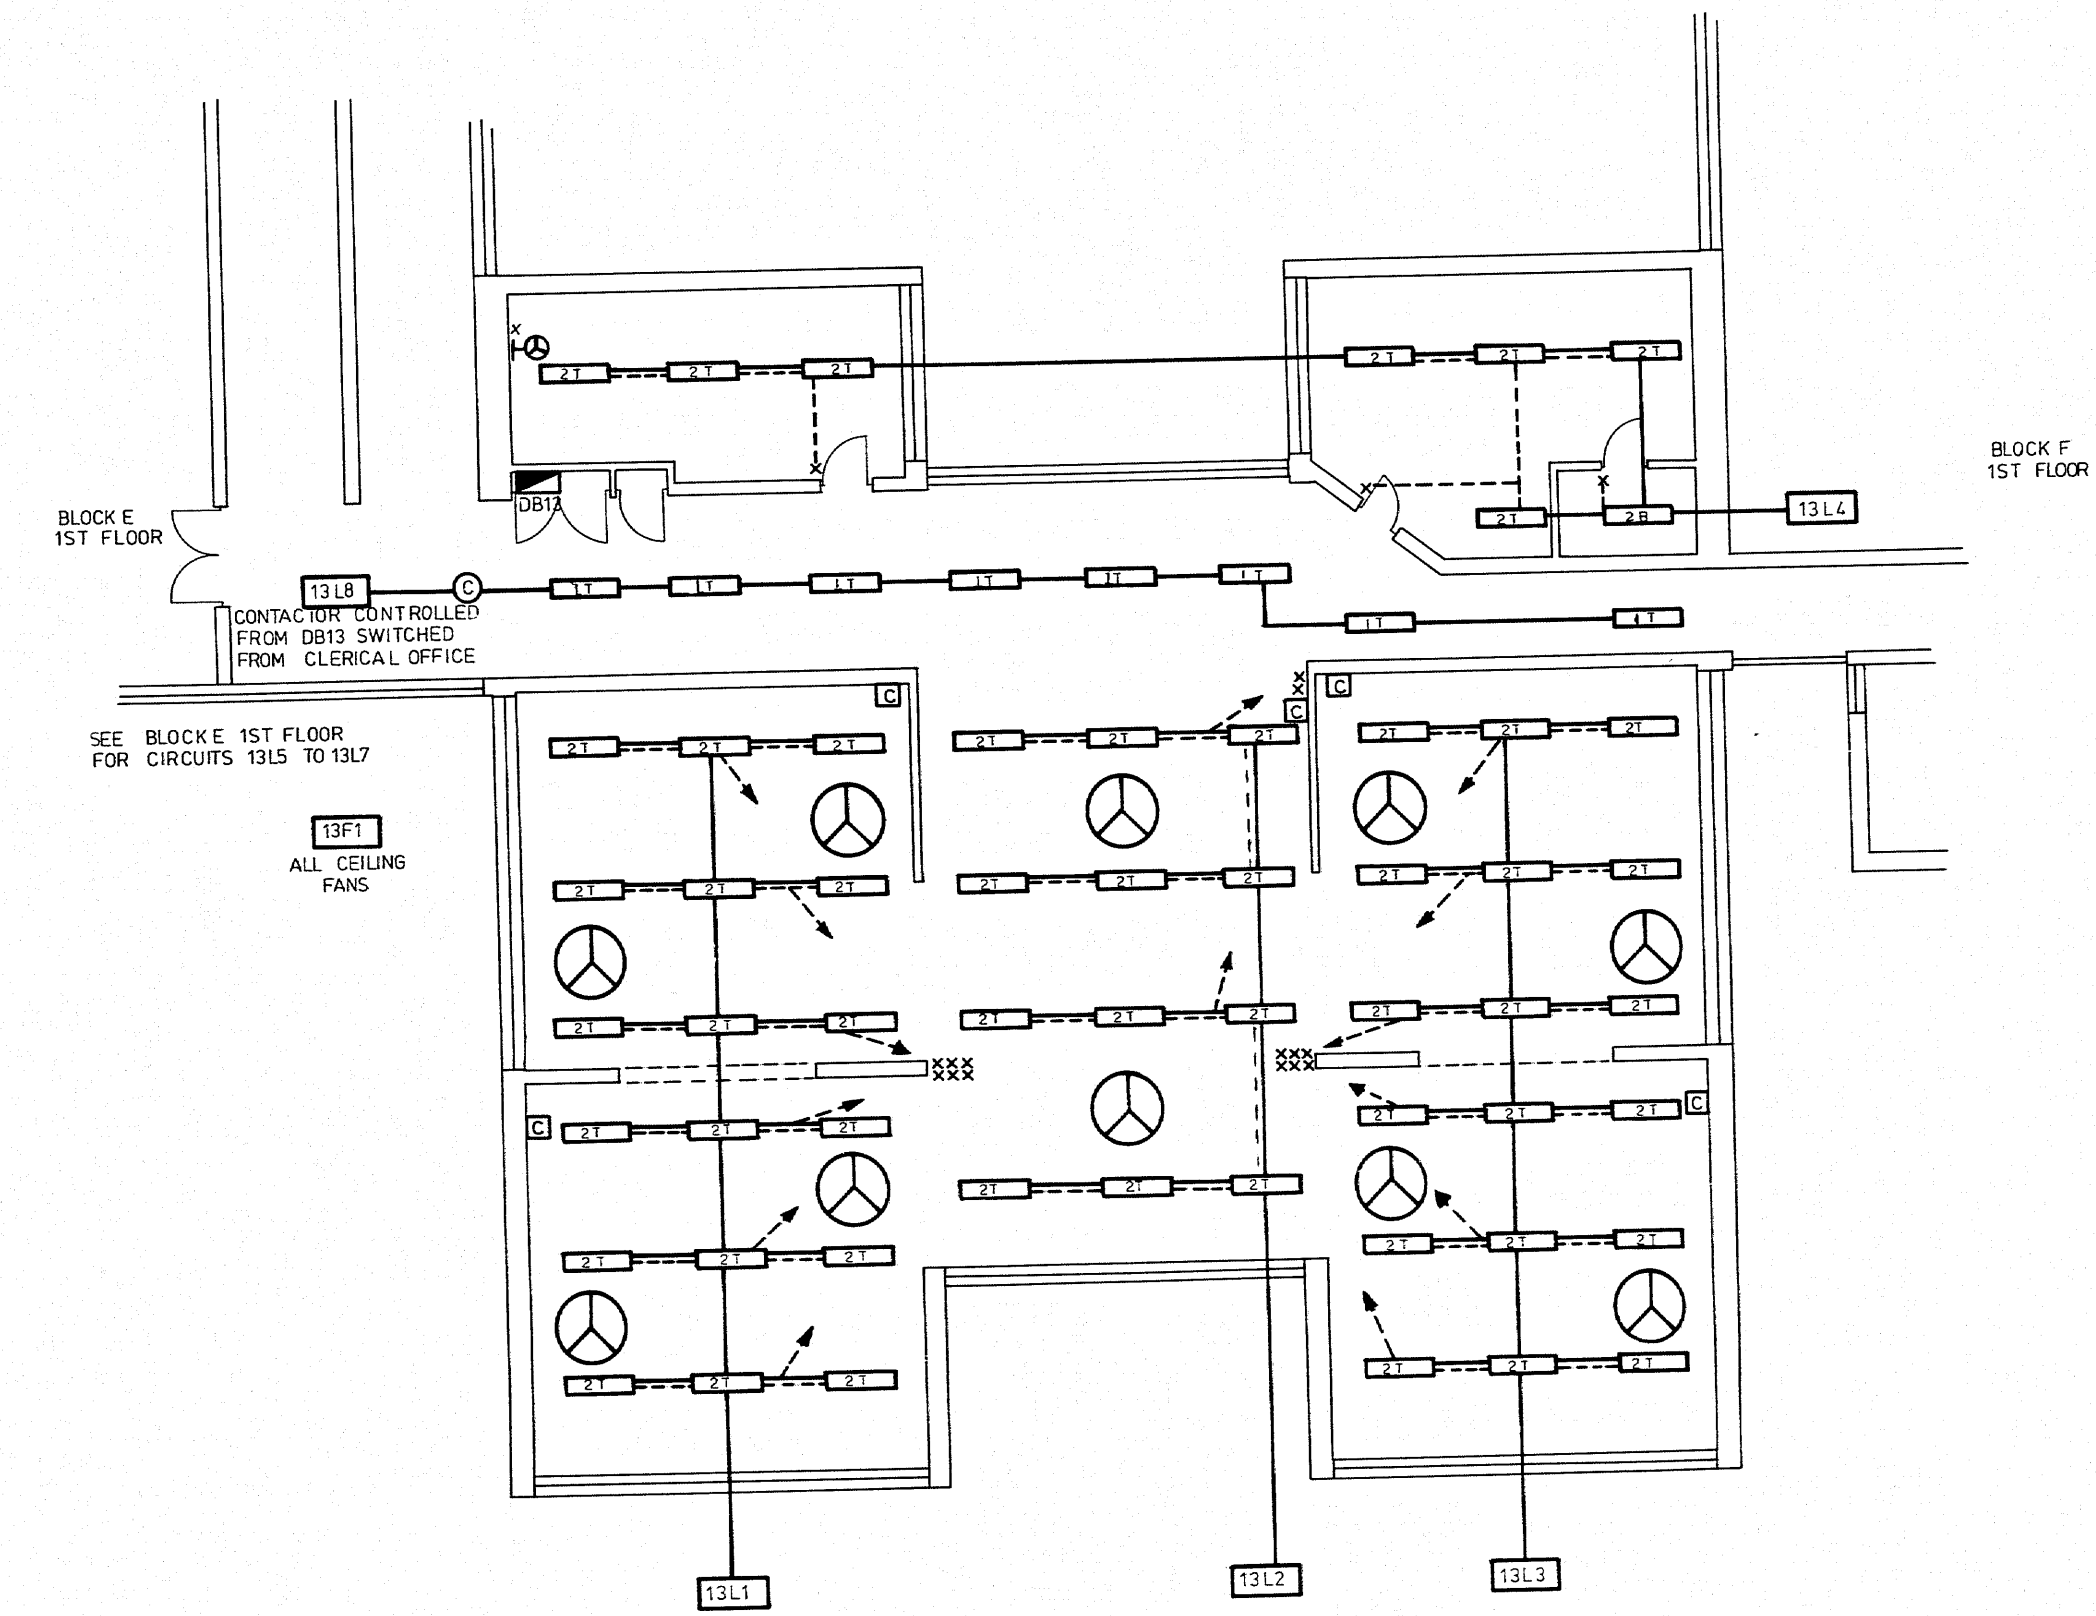

FIRST FLOOR

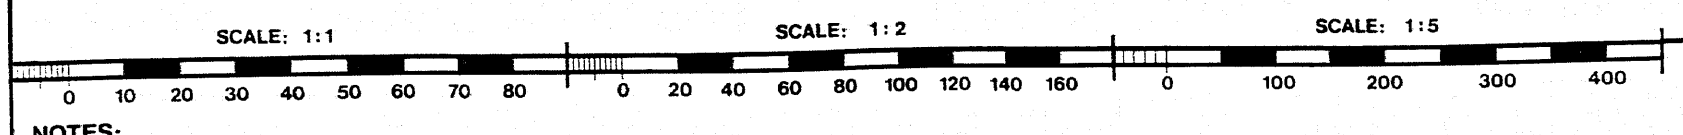

NOTES:

DEPARTMENT OF PUBLIC WORKS N.S.W. W. K. PILZ Director of Public Works	KELSO HIGH SCHOOL NEW SCHOOL	PLAN RM. No. SB2503-13/18
C. B. WEATHERBURN Government Architect Principal Engineer Schools <i>W. R. Bates 22/1/16</i>	FLEXIBLE LEARNING UNIT BLOCK K LIGHTING LAYOUT	NUMBER IN SET 28 SHEET NUMBER 18
W. R. BATES Deputy Chief Engineer Govt. Architect's Branch		SCALES: 1:100

ROLL 559



A1